
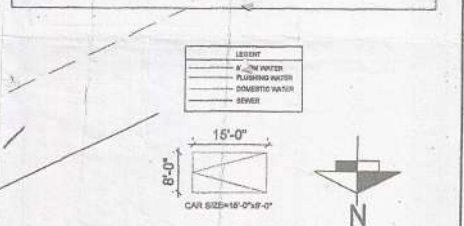


AREA STATEMENT	
PLOT AREA	2470 ACERS
PERMISSIBLE OR COV 40%	4478.541 SQ. FT.
PERMISSIBLE FAR 11.76	19838.417 SQ. FT.
PROPOSED GROUND COVERAGE	
CINEMA BLOCK-A	15722.175 SQ. FT.
CINEMA BLOCK-B	8181.432 SQ. FT.
CINEMA BLOCK-C	14477.278 SQ. FT.
TOTAL	38381.885 SQ. FT.
PROPOSED FAR	
GROUND FLOOR / FIRST FLOOR	
BLOCK-A	15722.175
BLOCK-B	8181.432
BLOCK-C	14477.278
TOTAL	38381.885
MUMMITY & MACHINE ROOM AREA	
BLOCK-A	889.024
BLOCK-B	393.750
BLOCK-C	393.750
TOTAL	1676.524
NET FAR ACHIEVED	
PARKING AREA CALCULATION	
REQUIRED PARKING FOR CINEMA @ 2500 PER 100 SQM. + 30% AREA OF CINEMA HALL	
TOTAL NO OF ECS REQU. FOR CINEMA	1601.303
REQUIRED PARKING FOR COMMERCIAL @ 2500 PER 100 SQM. (BLOCK-A & BLOCK-C)	
TOTAL PARKING REQU.	1601.303
PROPOSED PARKING	107.100
MECHANICAL	2.600
TOTAL ECS PROPOSED	107.100
TOTAL ECS @ 23/ECS	
SAY	
107.000 ECS	

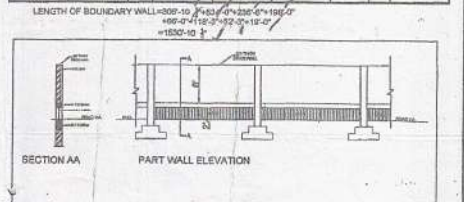


PROJECT TITLE
PROPOSED COMMERCIAL COMPLEX FOR PRIME PREMIUM STORE AT NH-64 AT VILLAGE, PESHAR KALAN, AND VILLAGE NAWATPUR, TEHSIL - RAJURA DISTT, PATIALA, PUNJAB

SCALE: NTS
DATE: OCT. 2014
DEALT: CHECKED: VG

ARCHITECT: Design Axis architects
104, MIDC INDUSTRIAL AREA, BHIMNATHU, ANDHRA PRADESH, NEW DELHI - 110028
PH: 8819928883, 28044831, 28048146
EMAIL: - vishag@dmilmail.com

ARCHITECT'S SIGN: *Vishag*

APPLICANT'S SIGN: *For M/s. Prime Premium Stores*

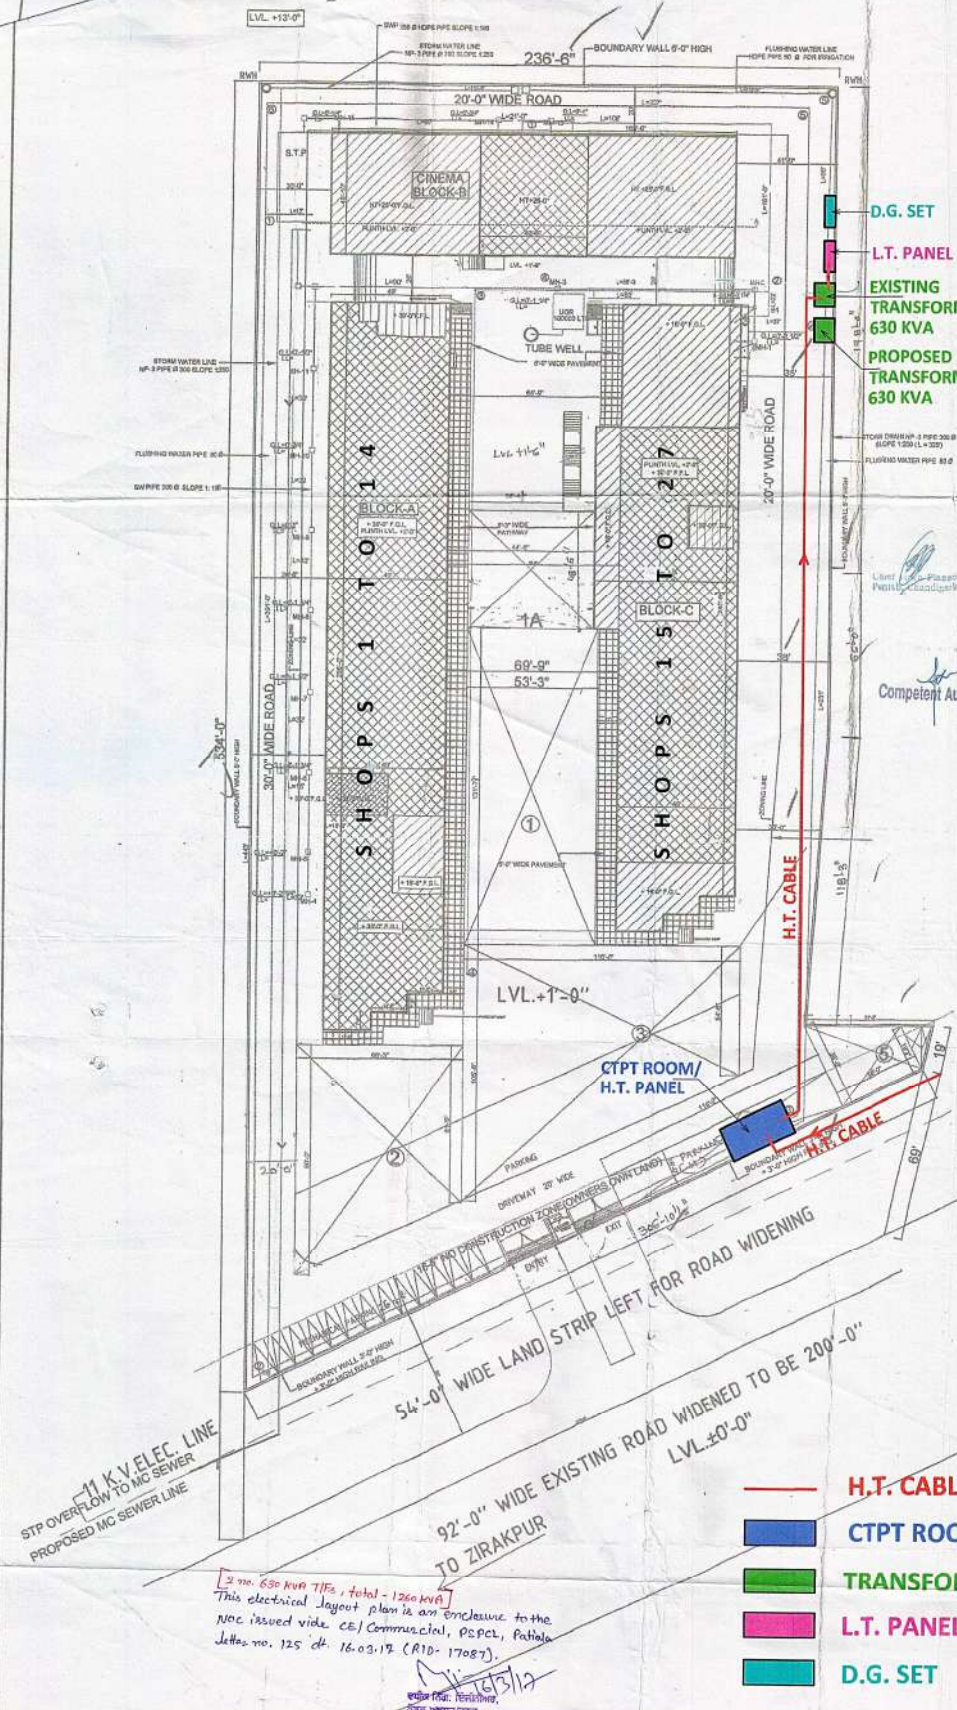

- H.T. CABLE
- CTPT ROOM/H.T. PANEL
- TRANSFORMER
- L.T. PANEL
- D.G. SET

2 nos. 630 KVA TFS, total - 1260 KVA
This electrical layout plan is an enclosure to the NOC issued vide CE/Commercial, PSPCL, Patiala letter no. 125 dt. 16.03.17 (R10-17087).

By: Chief Engineer/DS Circle
P.S.P.C.L., Patiala

For M/s. Prime Premium Stores
Auth. sign: Partner